





A
13
EXTERIOR PERSPECTIVE
DRAW NOT TO SCALE

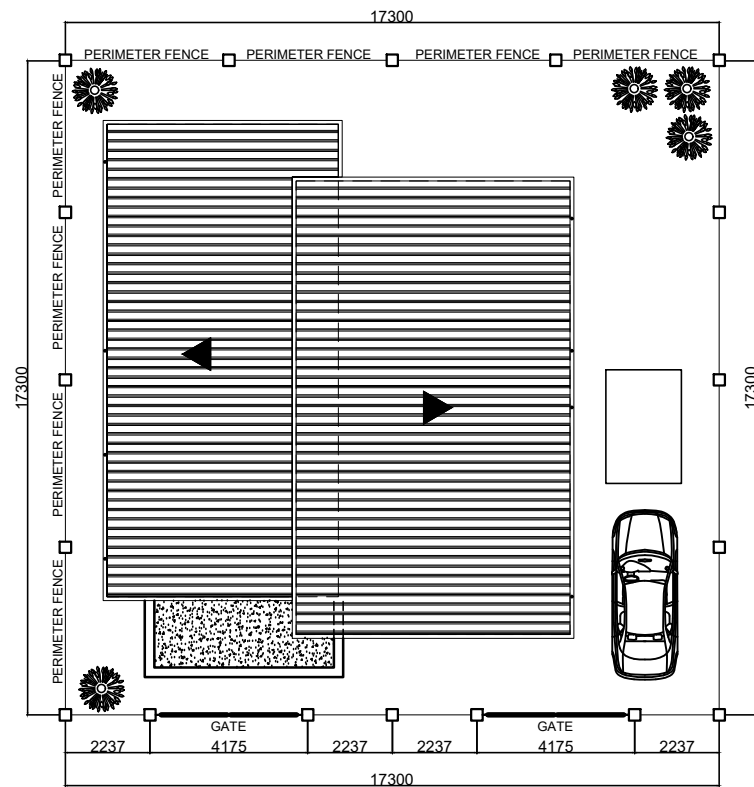

A
23
SITE DEVELOPMENT PLAN
SCALE 1:200 MTS

TABLE OF CONTENTS

SHEET NO.	TITLE	SET NO.
ARCHITECTURAL		
A-1	TABLE OF CONTENTS, PERSPECTIVE, LOCATION AND SITE DEVELOPMENT	1-13
A-2	FLOOR PLAN, ROOF PLAN	2-13
A-3	FRONT, RIGHT AND LEFT, REAR ELEVATIONS	3-13
A-4	SCHEDULE OF DOORS AND WINDOWS	4-13
A-5	SECTION THRU "A" & "B", SCHEDULE OF DOORS AND WINDOWS	5-13
STRUCTURAL		
S-1	FOUNDATION PLAN, ROOF BEAM PLAN	6-13
S-2	ROOF FRAMING PLAN, COLUMN AND FOOTING DETAIL	7-13
S-3	ROOF BEAM DETAIL, ROOF DECK SLAB, SCHEMATIC DESIGN OF TRUSS "TRUSS 1"	8-13
S-4	SCHEMATIC DESIGN OF TRUSS "TRUSS 2" SCHEMATIC DESIGN OF TRUSS "TRUSS 3" WALL FOOTING SECTION DETAIL	9-13
PLUMBING		
P-1	SEWER LAYOUT PLAN, WATERLINE LAYOUT PLAN LEGEND AND SYMBOLS	10-13
P-2	SEPTIC VAULT SECTION PLAN, GENERAL NOTES CATCH BASIN & GREASE TRAP SECTION DETAIL	11-13
ELECTRICAL		
E-1	LIGHTING & POWER LAYOUT PLAN, LEGEND AND SYMBOLS GENERAL SPECIFICATION	12-13
E-2	SCHEDULE OF ELECTRICAL LOADS ONE LINE DIAGRAM	13-13

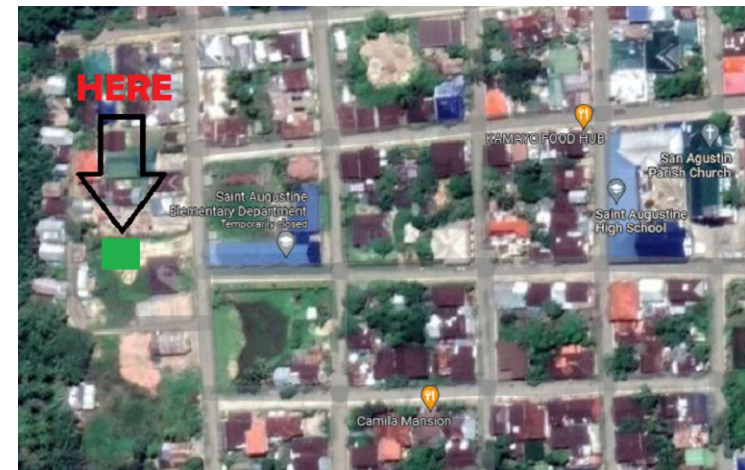

A
33
LOCATION MAP
DRAW NOT TO SCALE

REPUBLIC OF THE PHILIPPINES
PROVINCE OF SURIGAO DEL SUR
MUNICIPALITY OF SAN AGUSTIN
OFFICE OF THE BUILDING OFFICIALS

LAND USE & ZONING

LINE & GRADE

ARCHITECTURE

STRUCTURAL

MECHANICAL

SANITARY

FIRE SAFETY

SEAL:	PROJECT TITLE:	PROJECT OWNER:	SHEET CONTENT:	SHEET NO.	SET NO.	
ENGINEER	CONSTRUCTION OF SINGLE STORY RESIDENTIAL BUILDING	MR & MRS. LOUBERT C. LAYSON	EXTERIOR PERSPECTIVE LOCATION MAP SITE DEVELOPMENT PLAN TABLE OF CONTENTS	A 1	1 13	
PRC NO.:						TIN NO.:
PTR NO.:						DATE:
PLACED ISSUED:						LOCATION: SAN AGUSTIN, SURIGAO DEL SUR